



DO NOT SCALE FROM THIS DRAWING. USE FIGURED DIMENSIONS IN ALL CASES.  
VERIFY DIMENSIONS ON SITE AND REPORT ANY DISCREPANCIES TO THE DESIGNERS IMMEDIATELY.  
THIS DRAWING TO BE READ IN CONJUNCTION WITH THE DESIGNERS SPECIFICATION.  
© THIS DRAWING IS COPYRIGHT AND MAY ONLY BE REPRODUCED WITH THE DESIGNERS PERMISSION.

NOTES


- ALL DRAWINGS ARE TO BE READ IN CONJUNCTION WITH ALL RELEVANT SPECIFICATIONS, BILLS OF QUANTITIES, ARCHITECTURAL SERVICES AND ENGINEERING DRAWINGS.
- ALL LEVELS ARE IN METRES RELATED TO:  
DATUM: ORDNANCE DATUM MALIN HEAD  
REFERENCE SYSTEM: IRISH TRANSVERSE MERCATOR (ITM)  
GEOID: OSQM15
- ALL DIMENSIONS ARE IN MILLIMETRES, UNLESS NOTED OTHERWISE.
- ANY DISCREPANCIES BETWEEN THESE DOCUMENTS SHALL BE BROUGHT TO THE ATTENTION OF THE ENGINEER.
- DRAWINGS ARE NOT TO BE SCALED.

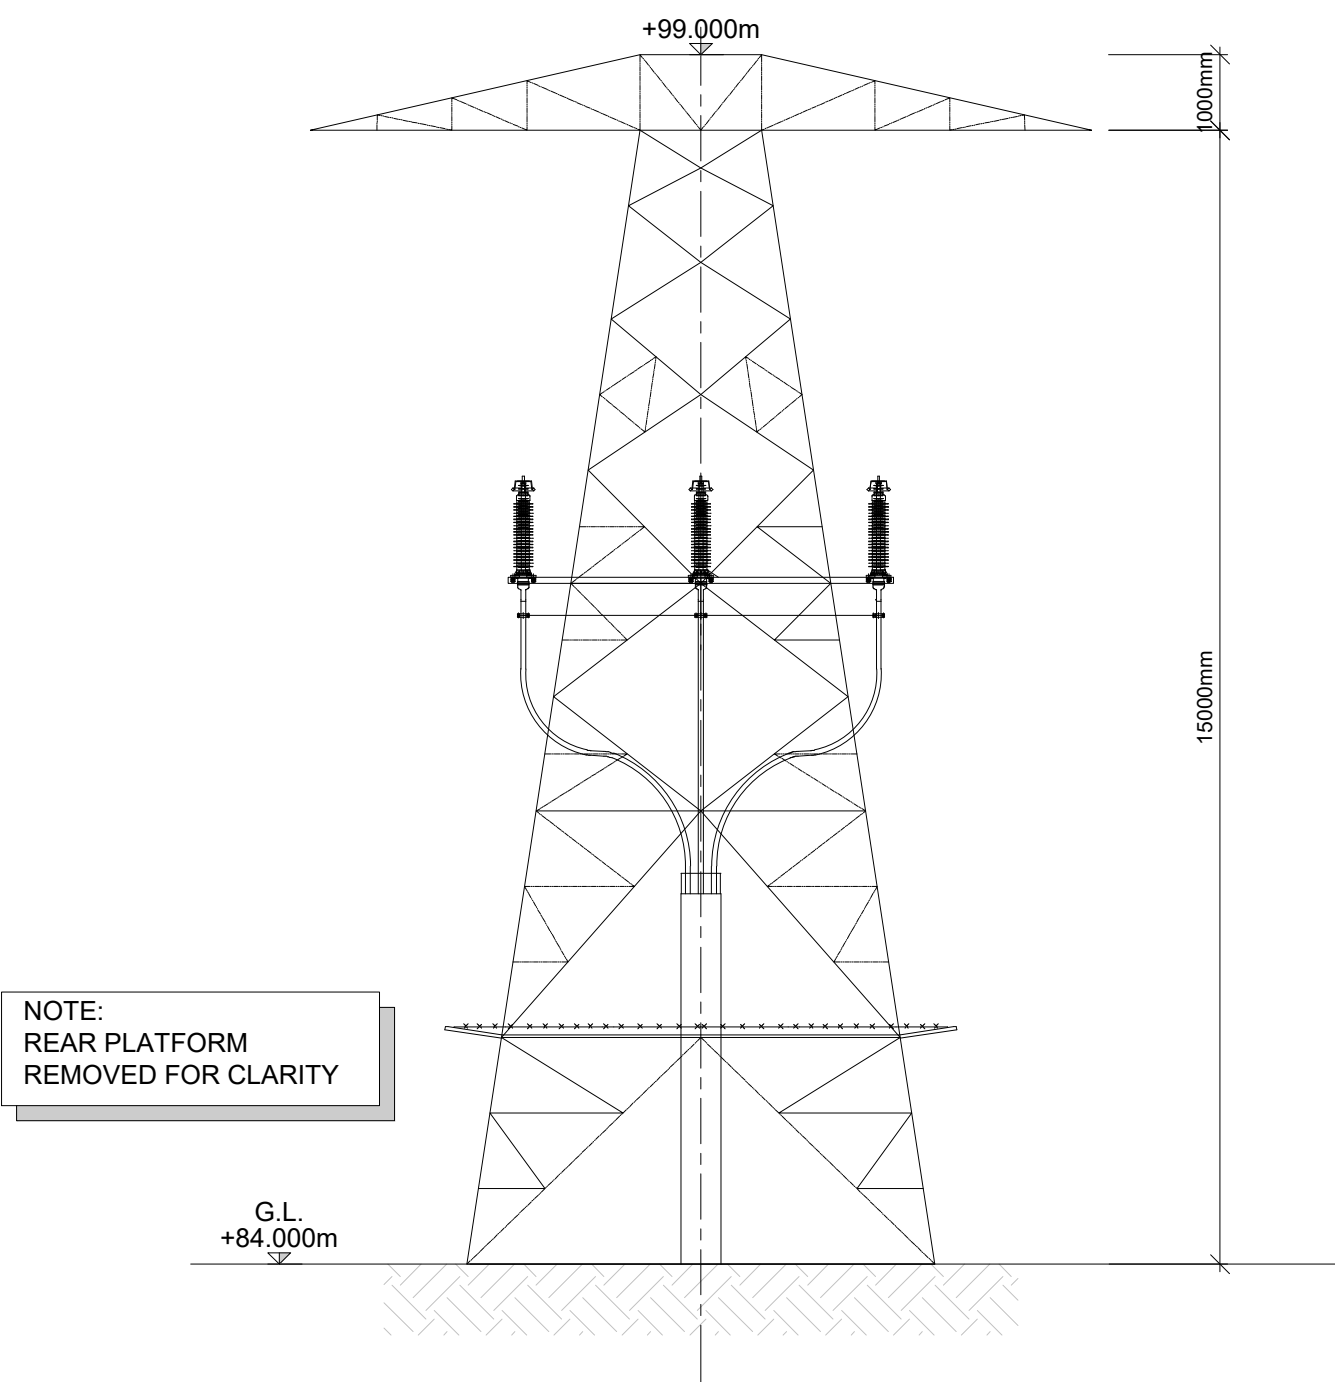


FRONT ELEVATION  
SCALE 1: 100

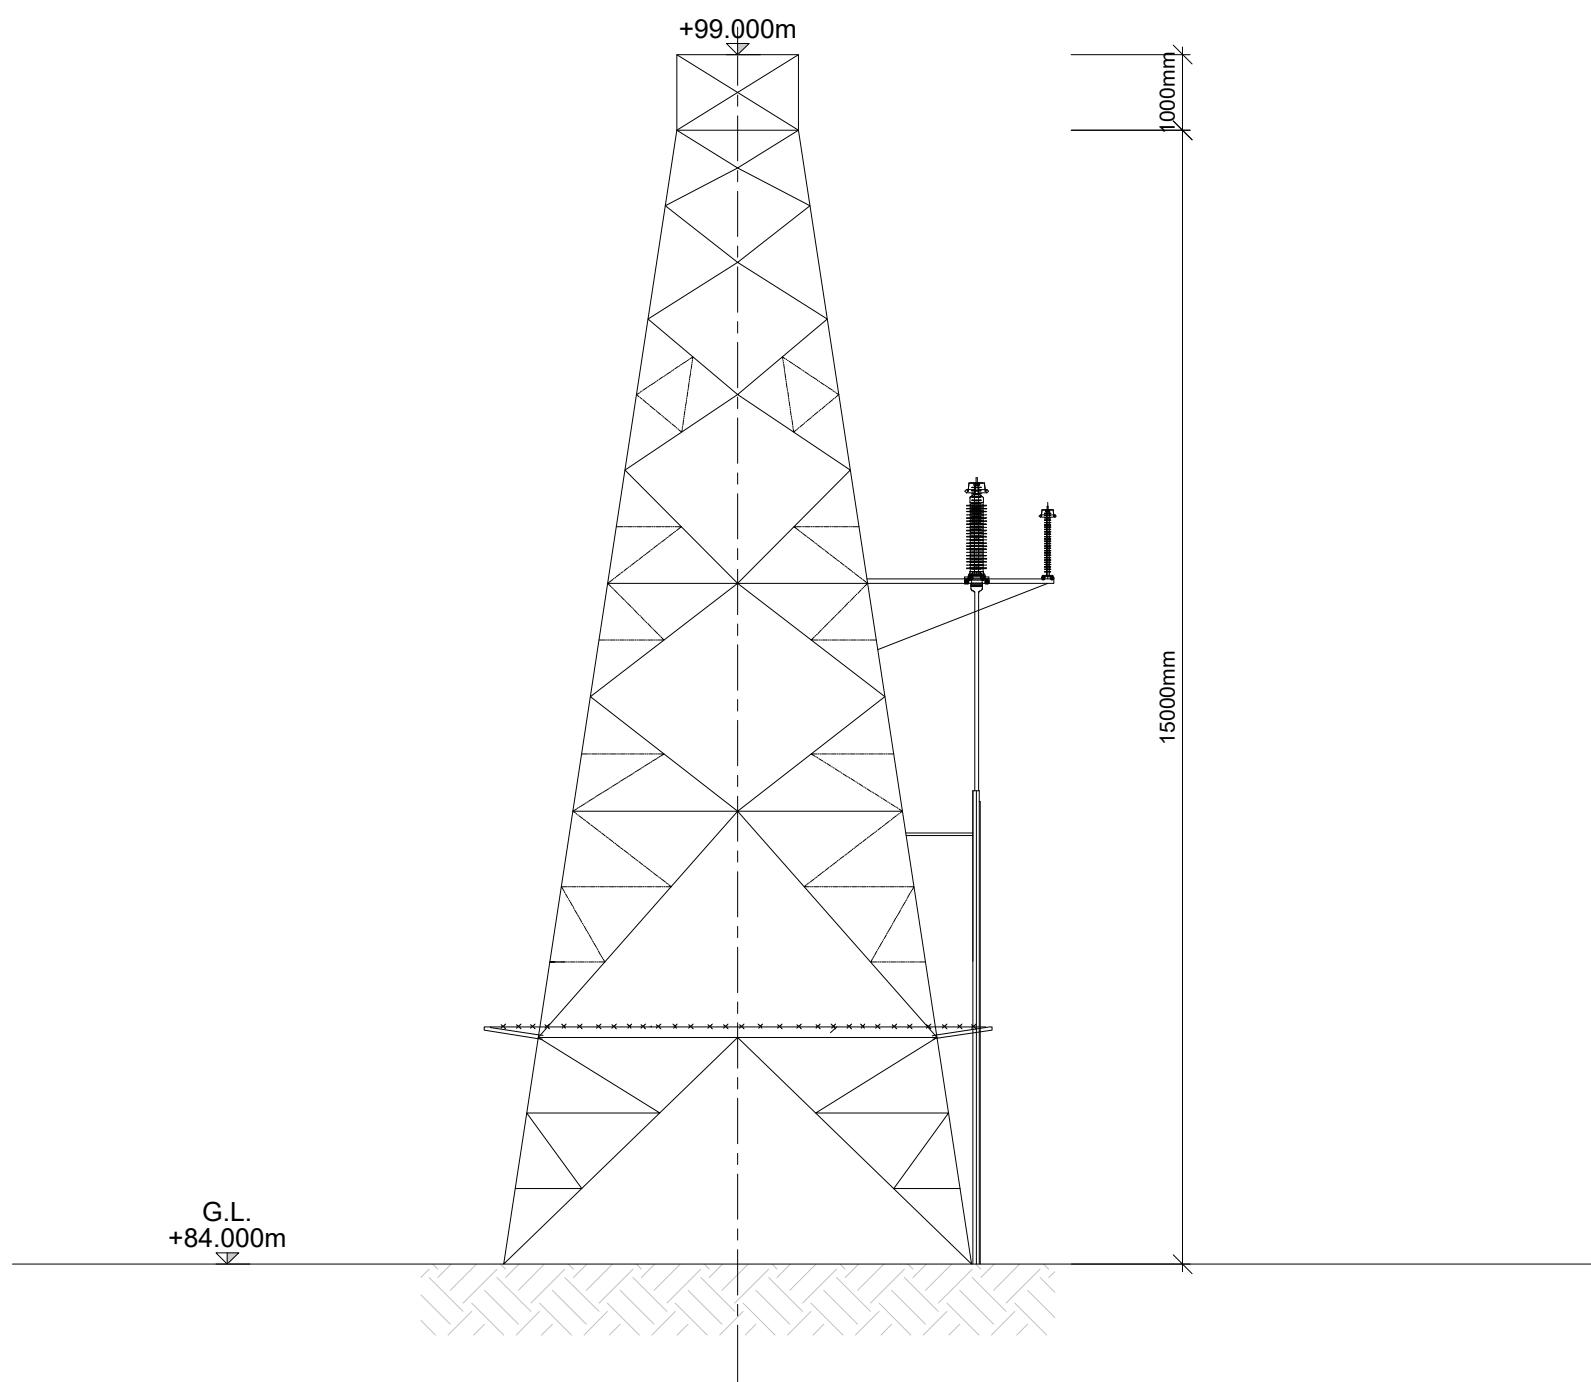


SIDE ELEVATION  
SCALE 1: 100

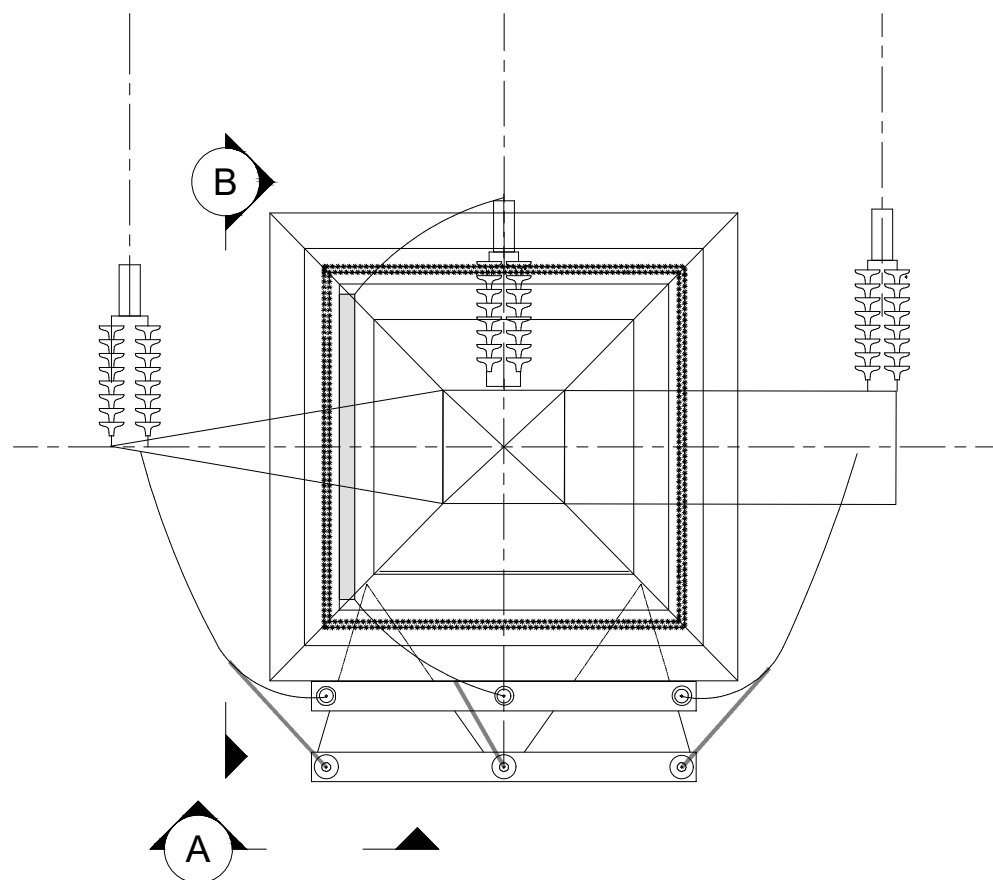

PLAN VIEW  
SCALE 1: 100

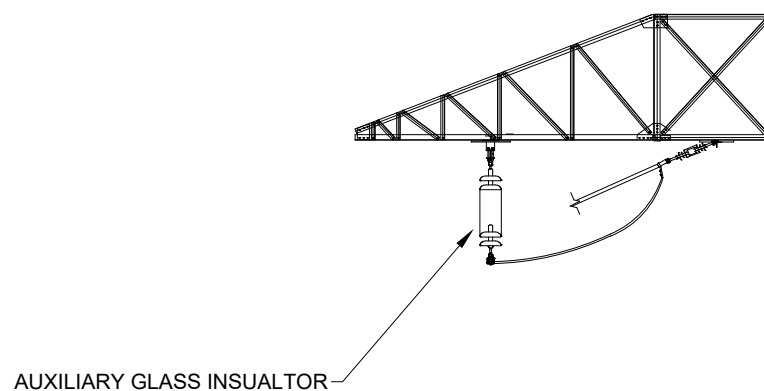

SECTION A  
SCALE 1: 100

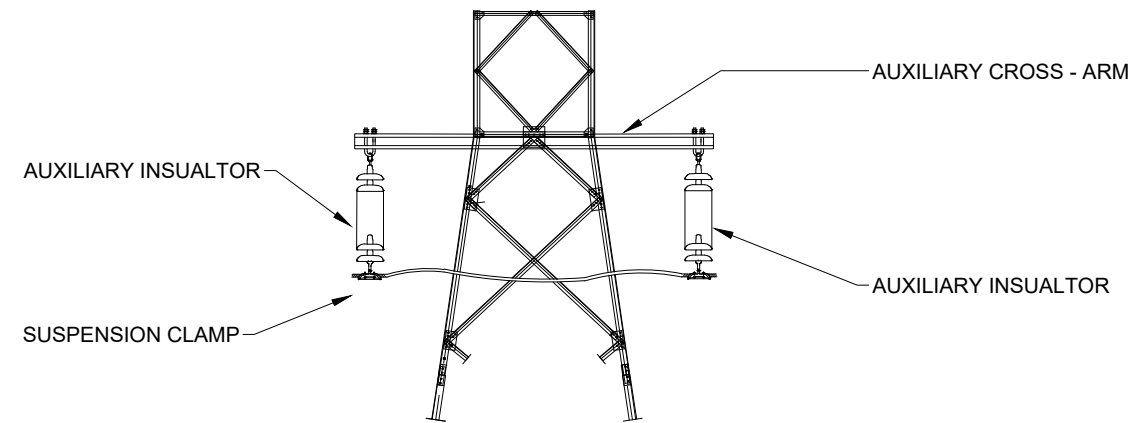

SECTION B  
SCALE 1: 100

P05 26/05/25	ISSUED FOR INFORMATION	SR	IB
P04 22/05/25	ISSUED FOR INFORMATION	S.R.	I.B.
P03 16/10/24	ISSUED FOR INFORMATION	O.R.	I.B.
P02 03/10/24	ISSUED FOR INFORMATION	S.S.	I.B.
P01 03/09/24	ISSUED FOR INFORMATION	S.S.	I.B.
REV	DATE	DESCRIPTION	BY APP

PROJECT:  
DREHID SUBSTATION

TITLE:  
110kV OVERHEAD LINE INTERFACE  
TOWER

CLIENT:  
NORTH KILDARE WF LTD.



DRAWN: S.S.	CHECKED: C.F.	APPROVED: I.B.
PROJECT NUMBER: 23727	DATE: AUG' 24	SCALE @ A1: 1:100
STATUS DESCRIPTION FOR INFORMATION		STATUS: S2

DRAWING NUMBER: 23727 - MWP -XX-XX-DR-S-4300	REV: P05
---	-------------